


年	月	日
年	月	日
年	月	日
年	月	日
深	化	
电	气	
给	排	
水	水	
空	调	

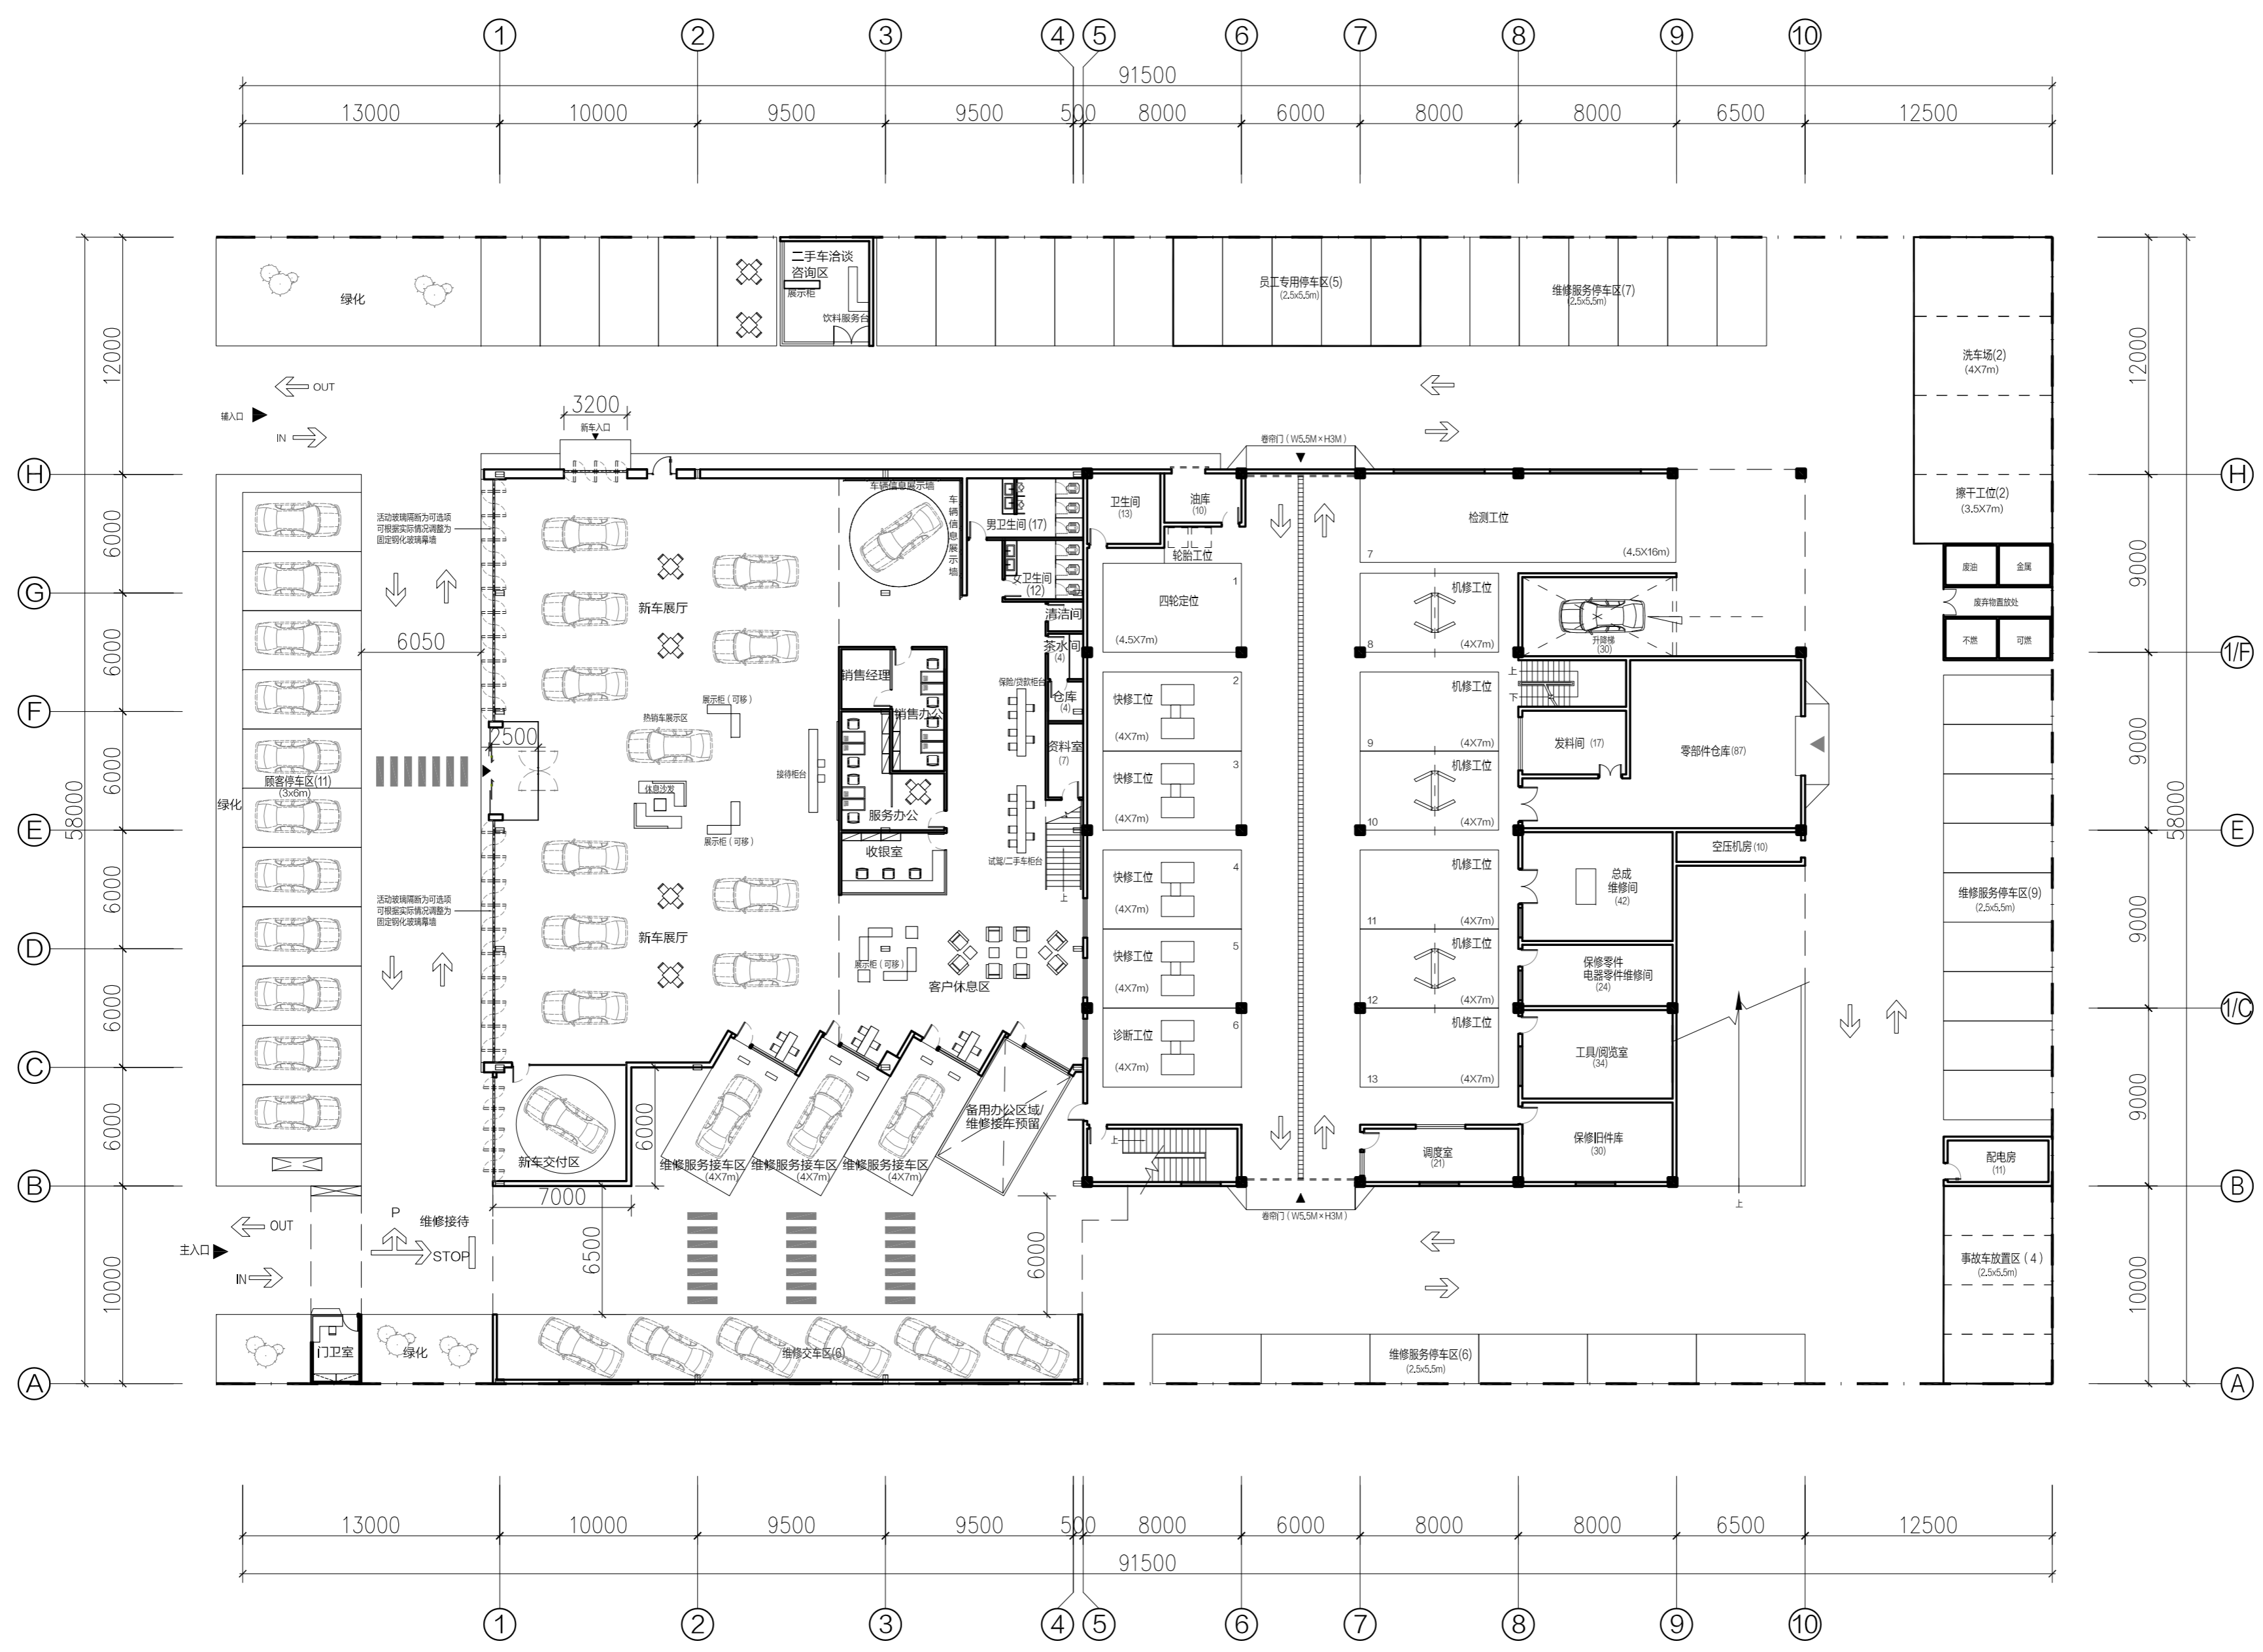

This drawing is not valid for construction or other purposes unless separately certified.

Notes:

1. This drawing and design are copyright and no party are allowed to reproduce without the permission of the Cityinno.
2. Do not scale drawing. Use written dimensions or grid line only. Measurements for existing work should be checked on site.
3. Drawing user is responsible for notifying Cityinno if confusion arises on site or if dimensions/details are missing from drawing set before proceeding on site.
4. This drawing is to be read in conjunction with the Specification and Condition of Contract.
5. Please always refer to the latest drawing for site construction.

除经特别证明外，本图不可作建筑或其他用途。

备注:

1. 本图版权为本公司所有，任何人士如未获允许不得翻印任何部分。
2. 请列明尺寸或以方格代替比例。尺寸度量以地盘实物为准。
3. 图纸上所有遗漏请知会城市创意。
4. 参看本图时，请同时阅读和约条款细则及规则。
5. 本图以最后更正之版本做实，其他版本，自动作废。



Design & Project Management Consultancy:  
项目设计及项目管理顾问:

城市创意建筑设计有限公司

Revision 修订

No. 编号	Date 日期	Description 摘要	Drawn by 制图人	Checked by 校对入

Reviewed By 审定

Approved By 审核

Charged By 项目负责

Designer 设计

Drainage 给排水设计

Air Conditioning 空调设计

Electrical 电气设计

Project 项目:  
广汽丰田标准建设  
C级标准店

Drawing Title 图纸名称:  
首层总平面图

Scale 比例:  
A2-1: 250

Project Number 工程编号:

Drawing Number 图号:  
P-01

Ref. Number 索引:

PLAN VIEW 首层总平面布置图 SCALE 1:250